


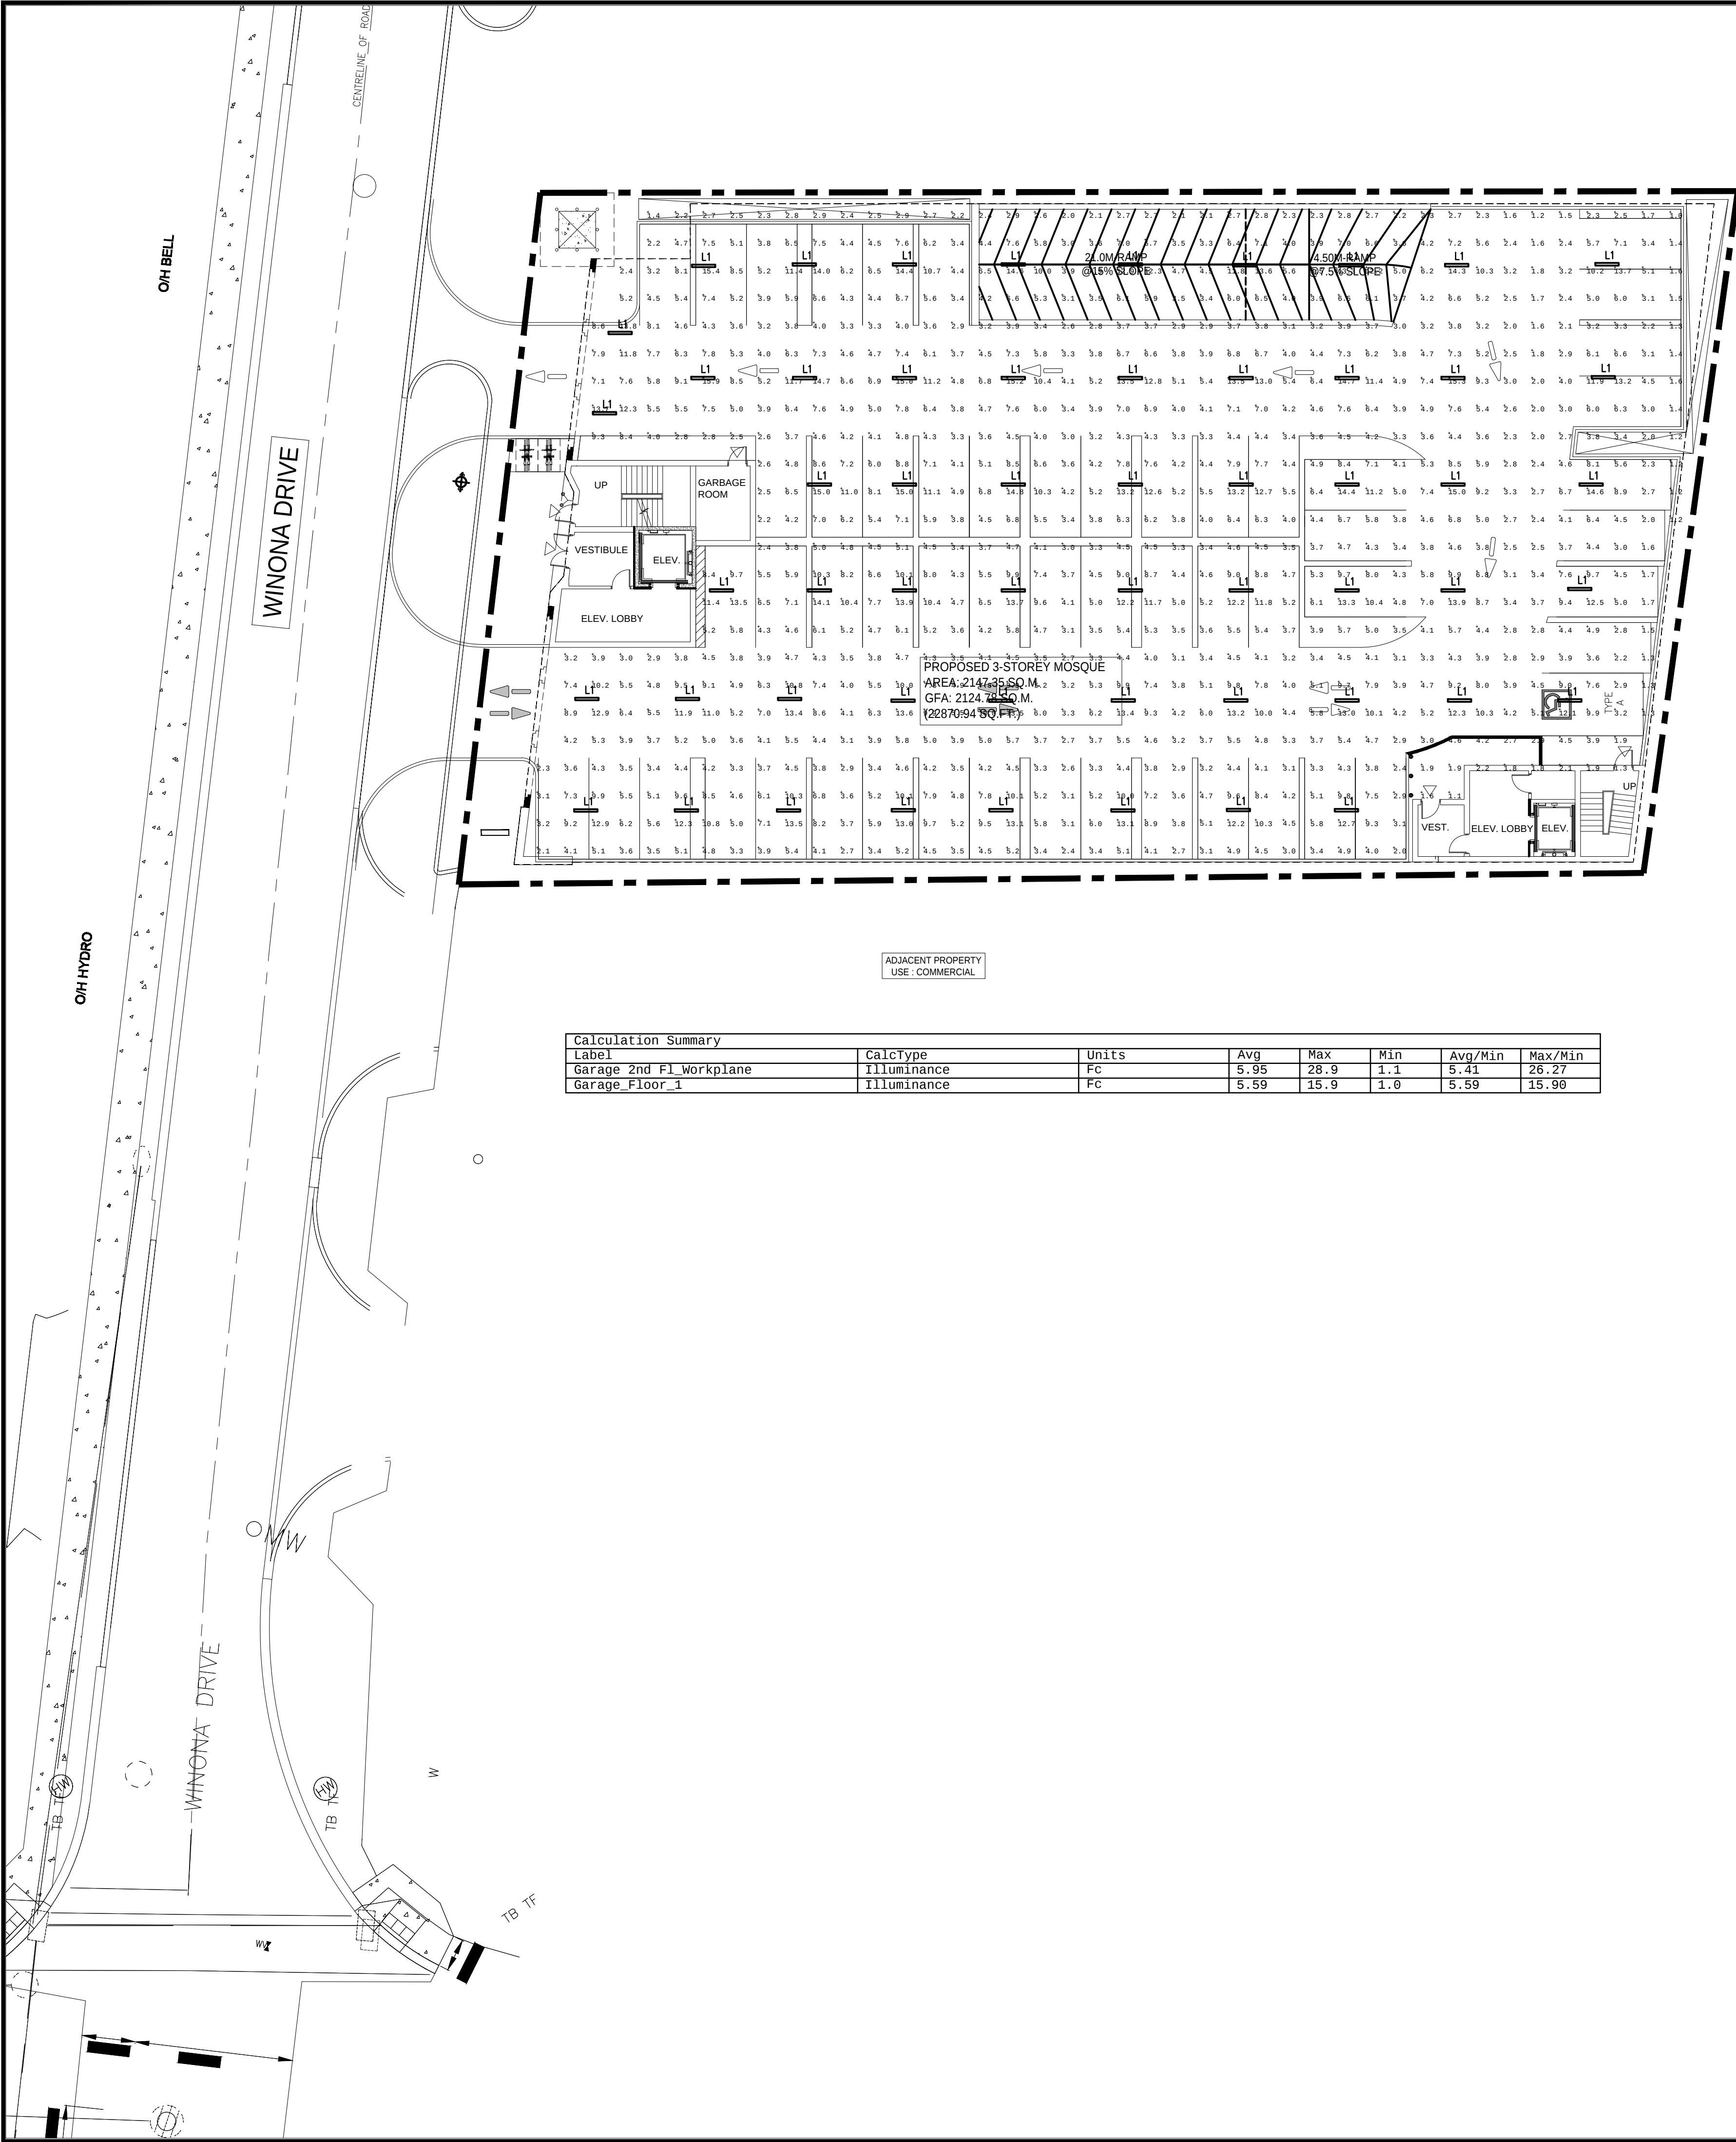


Calculation Summary							
Label	CalcType	Units	Avg	Max	Min	Avg/Min	Max/Min
Garage 2nd Fl Workplane	Illuminance	FC	5.95	28.9	1.1	5.41	26.27
Garage Floor 1	Illuminance	FC	5.59	15.9	1.0	5.59	15.90

LUMINAIRE SCHEDULE	
L1	4' LONG, SURFACE MOUNTED LED, ENCLOSED & FULLY GASKETED LUMINAIRE (17.5W, 1575 LUMENS), 4000K, FROSTED IMPACT RESISTANT ACRYLIC SHIELDING, 120V DRIVER HEW# 96-4-L40-840-HAIFR-(L25)-DIM-120V SIGNIFY, COOPER, LITHONIA

Jain

7405 East Danbro Crescent, 2nd Floor
Mississauga, Ontario, L5N 6P8
Tel: 905 285 9900, Fax: 905 567 5246
Email : mail@jainconsultants.com

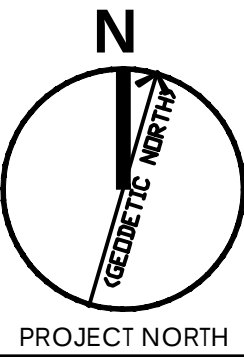

3.	NOV.17'25	RE-ISSUED FOR SITE PLAN APPROVAL	RH
2.	MAR.10'25	RE-ISSUED FOR SITE PLAN APPROVAL	RH
1.	FEB.19'25	ISSUED FOR SITE PLAN APPROVAL	RH
NO.	DATE	VERSION	Dwn.

This drawing is copyright property of
'n Architecture Inc'. Not to be reproduced.
Contractor must verify all job dimensions,
drawings, details and specifications and report
any discrepancies to the architect before
proceeding with work.


PROJECT:
**27 VINONA DR,
WHITCHURCH
STOUFFVILLE, ON
PLACE OF
WORSHIP-MOSQUE**

DRAWING TITLE:
**SITE PLAN
-ELECTRICAL**

DRAWN BY: CV	DATE: NOV.17'2025
CHECKED BY: RH	SCALE: 1:200
PROJECT NO.:	DRAWING NO.:

22-71

E-1.1

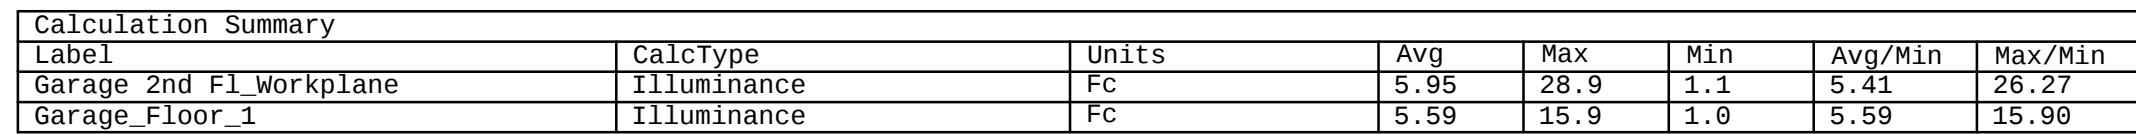


LUMINAIRE SCHEDULE

L1	4' LONG, SURFACE MOUNTED LED, ENCLOSED & FULLY GASKETED LUMINAIRE (17.5W, 1575 LUMENS), 4000K, FROSTED IMPACT RESISTANT ACRYLIC SHIELDING, 120V DRIVER. MEW# 96-4-L40-840-HIAFR-(L25)-DM-120V SIGNIFY, COOPER, LITHONIA
----	---

Jain

7405 East Danbro Crescent, 2nd Floor
Mississauga, Ontario, L5N 6P8
Tel: 905 285 9900, Fax: 905 567 5246
Email : mail@jainconsultants.com

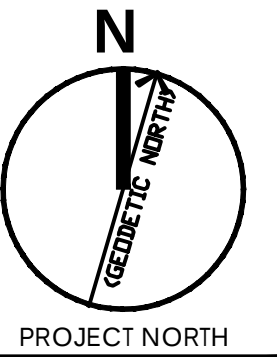

3.	NOV.17'25	RE-ISSUED FOR SITE PLAN APPROVAL	RH
2.	MAR.10'25	RE-ISSUED FOR SITE PLAN APPROVAL	RH
1.	FEB.19'25	ISSUED FOR SITE PLAN APPROVAL	RH
NO.	DATE	VERSION	Dwn.

This drawing is copyright property of 'n Architecture Inc'. Not to be reproduced. Contractor must verify all job dimensions, drawings, details and specifications and report any discrepancies to the architect before proceeding with work.

PROJECT:
27 VINONA DR,
WHITCHURCH
STOUFFVILLE, ON
PLACE OF
WORSHIP-MOSQUE

DRAWING TITLE:

SECOND FLOOR
COVERED PARKING
-LIGHTING

DRAWN BY: CV	DATE: NOV.17'2025
--------------	-------------------

CHECKED BY: RH	SCALE: 1:200
----------------	--------------

PROJECT NO.:	DRAWING NO.:
--------------	--------------

22-71	E-1.2
-------	-------