


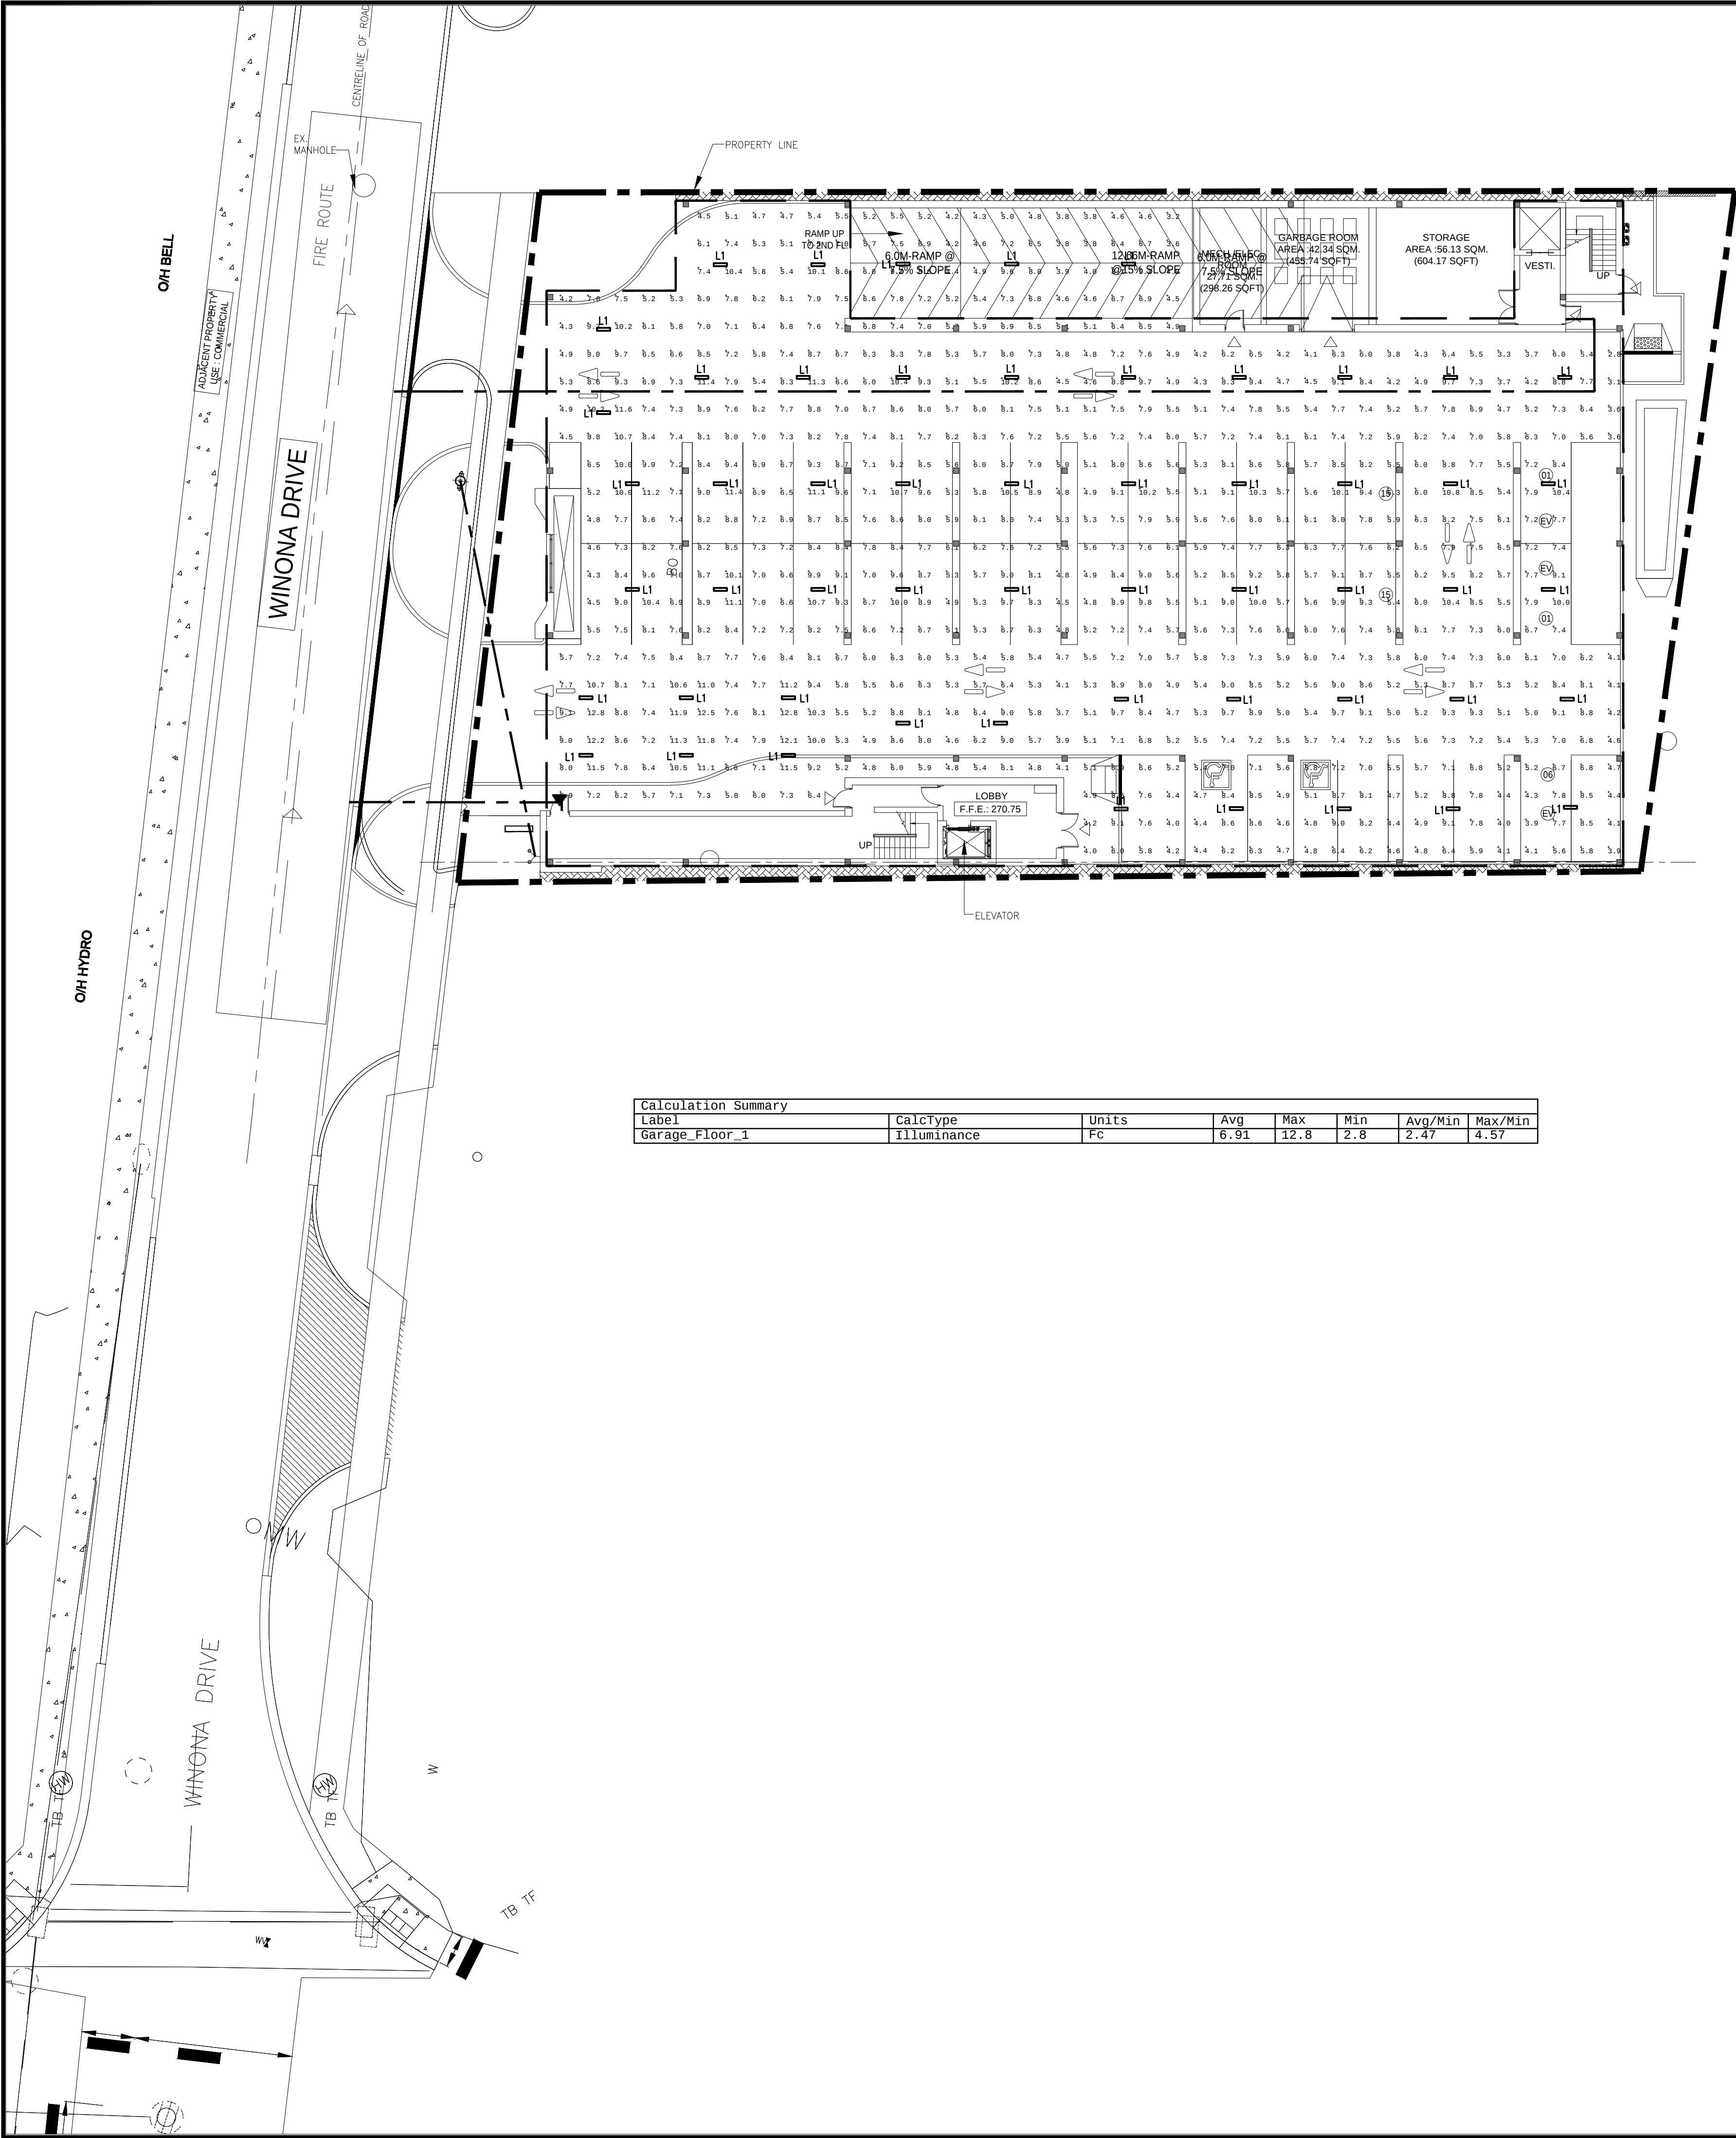


Calculation Summary						
Label	CalcType	Units	Avg	Max	Min	Avg/Min
Garage_Floor_1	Illuminance	Fc	6.91	12.8	2.8	2.47

LUMINAIRE SCHEDULE	
L1	2' LONG, SURFACE MOUNTED LED, ENCLOSED & FULLY GASKETED LUMINAIRE (22.0W, 1188 LUMENS), 4000K, FROSTED IMPACT RESISTANT ACRYLIC SHIELDING, 120V DRIVER, HEW# 97-2-130-840-FR SIGNIFY, COOPER, LITHONIA

Jain

7405 East Danbro Crescent, 2nd Floor
Mississauga, Ontario, L5N 6P8
Tel: 905 285 9900, Fax: 905 567 5246
Email : mail@jainconsultants.com

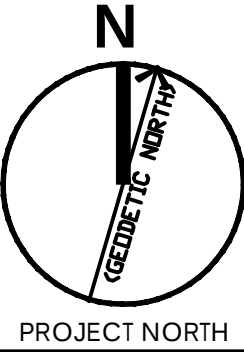

2.	MAR.10'25	RE-ISSUED FOR SITE PLAN APPROVAL	RH
1.	FEB.19'25	ISSUED FOR SITE PLAN APPROVAL	RH
NO.	DATE	VERSION	Dwn.

This drawing is copyright property of
"n Architecture Inc". Not to be reproduced.
Contractor must verify all job dimensions,
drawings, details and specifications and report
any discrepancies to the architect before
proceeding with work.


PROJECT:
27 VINONA DR,
WHITCHURCH
STOUFFVILLE, ON
PLACE OF
WORSHIP-MOSQUE

DRAWING TITLE:
SITE PLAN
-ELECTRICAL

DRAWN BY: CV	DATE: MARCH.10'2025
CHECKED BY: RH	SCALE: 1:200
PROJECT NO.:	DRAWING NO.:


22-71

 E-1.1



Jain

7405 East Danbro Crescent, 2nd Floor
Mississauga, Ontario, L5N 6P8
Tel: 905 285 9900, Fax: 905 567 5246
Email : mail@jainconsultants.com

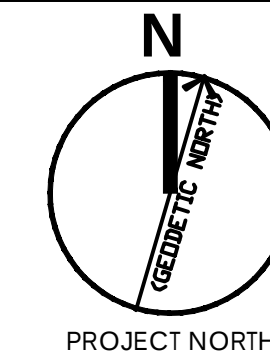

2.	MAR.10'25	RE-ISSUED FOR SITE PLAN APPROVAL	RH
1.	FEB.19'25	ISSUED FOR SITE PLAN APPROVAL	RH
NO.	DATE	VERSION	Dwn.

This drawing is copyright property of 'n Architecture Inc'. Not to be reproduced. Contractor must verify all job dimensions, drawings, details and specifications and report any discrepancies to the architect before proceeding with work.

PROJECT:
27 VINONA DR,
WHITCHURCH
STOUFFVILLE, ON
PLACE OF
WORSHIP-MOSQUE

DRAWING TITLE:

LIGHTING LAYOUT
-SECOND FLOOR
(PARKING SPACE)

DRAWN BY: CV	DATE: MARCH.10'2025
CHECKED BY: RH	SCALE: 1:200
PROJECT NO.:	DRAWING NO.:

22-71	E-1.2
-------	-------