
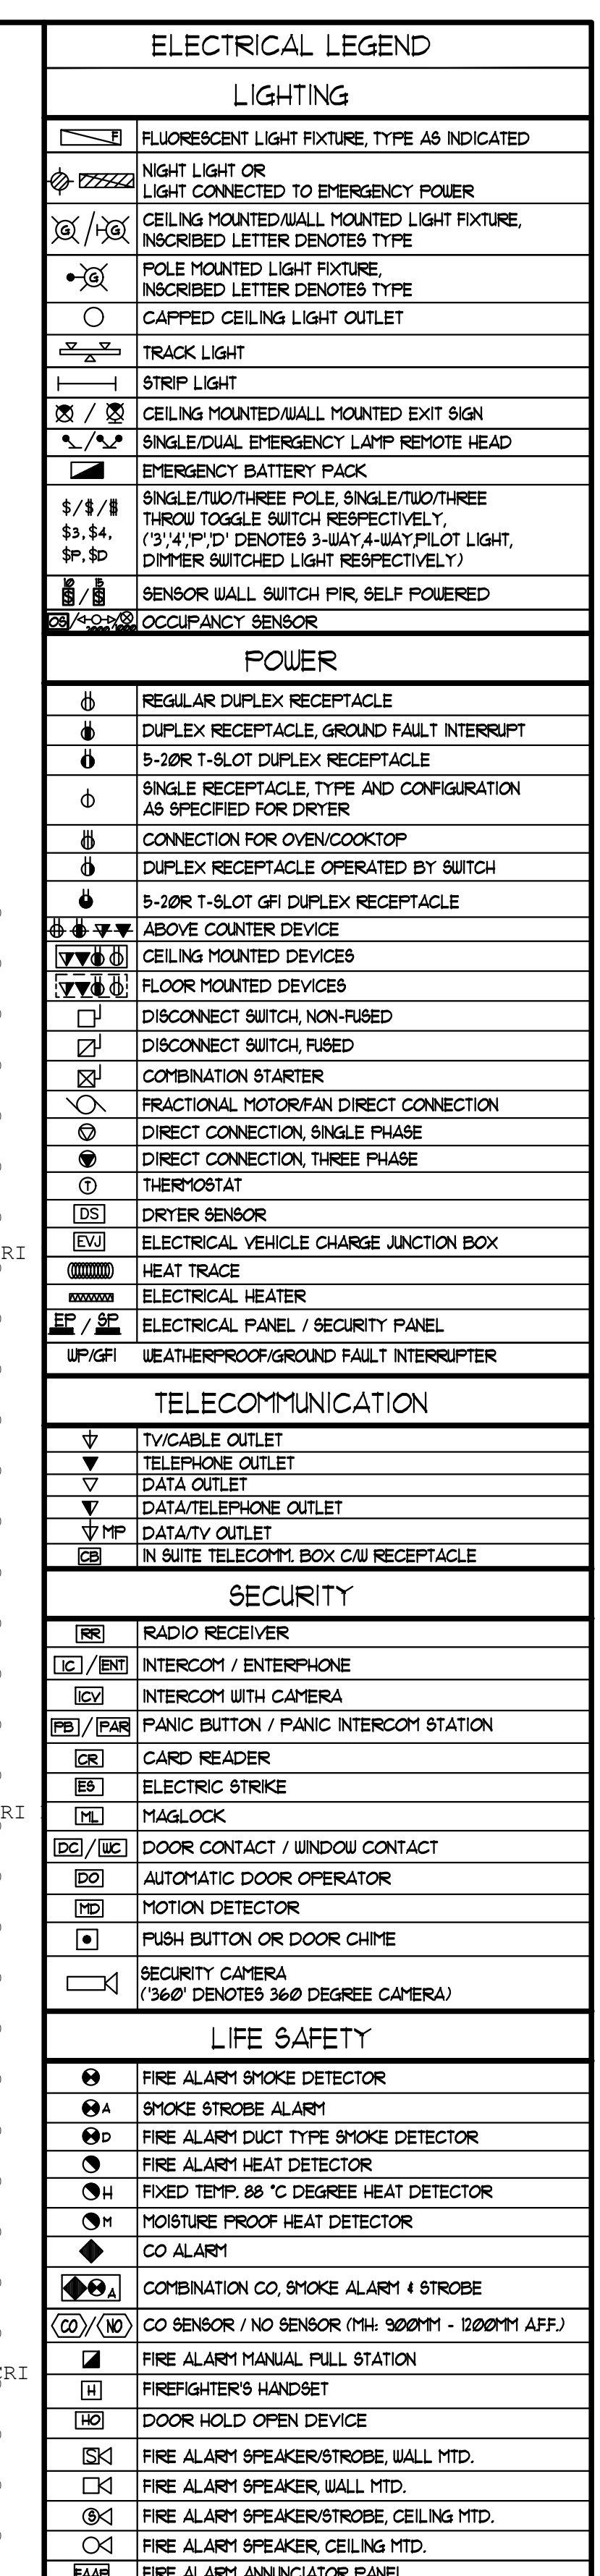
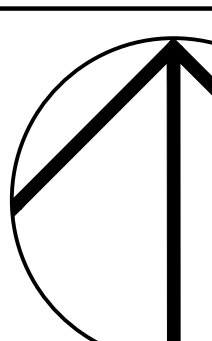


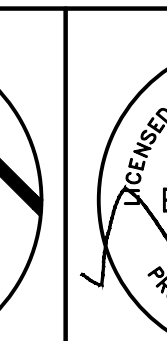

Calculation Summary							
Label	CalcType	Units	Avg	Max	Min	Avg/Min	Max/Min
E Drive Aisle	Illuminance	Fc	1.90	4.7	0.2	9.50	23.50
N Drive Aisle	Illuminance	Fc	2.55	7.2	0.8	3.19	9.00
NW Parking Lot	Illuminance	Fc	2.21	4.8	0.5	4.42	9.60
Outer Landscape	Illuminance	Fc	0.51	4.7	0.0	N.A.	N.A.
Past Property Line	Illuminance	Fc	0.29	2.8	0.0	N.A.	N.A.
S Drive Aisle	Illuminance	Fc	2.27	8.5	0.1	22.70	85.00
W Drive Aisle	Illuminance	Fc	2.56	6.1	0.2	12.80	30.50
W Gravel Parking	Illuminance	Fc	1.24	3.3	0.0	N.A.	N.A.

[illegible][illegible]

ILLUMINATED DOOR LOCKED INDICATOR			
PUSH TO LOCK			
DUAL LENGTH PLASTIC STRIP			
01/16/05	2	RE-ISOLED FOR SPA SUBMISSION	E.P.
06/28/04	1	ISSUED FOR SPA SUBMISSION	T.M.
DATE	NO.	DESCRIPTION	BY
MARK VOID ALL PRINTS DATED PREVIOUS TO FINAL DATE ABOVE			
REVISIONS			
CONTRACTOR MUST CHECK AND VERIFY ALL DIMENSIONS AND CONDITIONS ON THE JOB AND REPORT DISCREPANCIES TO THE ENGINEERS BEFORE PROCEEDING WITH THE WORK. THIS DRAWING IS THE PROPERTY OF THE ENGINEERS AND MUST BE RETURNED UPON COMPLETION OF THE WORK.			
DRAWINGS ARE NOT TO BE SCALED			
54 West Beaver Creek Road, Unit 200 Richmond Hill, Ontario L4B 1G5 Tel: 905 882-5445			
			
DRAWING TITLE: ELECTRICAL SITE PLAN SPA			
PROJECT TITLE: INDUSTRIAL BUILDING			
35 GORDON COLLINS DRIVE GORELEY ONTARIO			
DRAWN BY:	CHECKED BY:	SCALE:	
T.M.	T.M.	N.T.S.	
DATE:	PROJECT NUMBER:	DRAWING NUMBER:	
042024	2401	E-1	